


ITEM NO.	TO BE CONSTRUCTED	UNIT	PLAN QUANTITY	AS-BUILT QUANTITY
5	EXCAVATION, UNCLASSIFIED	C.Y.	265	
6	DENSE GRADED AGGREGATE BASE COURSE, 6" THICK	S.Y.	865	
7	HOT MIX ASPHALT BASE COURSE, MIX 19M64, 3" THICK	TON	162	
8	HOT MIX ASPHALT SURFACE COURSE, MIX 9.5M64, 2" THICK	TON	108	
9	8" X 18" CONCRETE VERTICAL CURB	L.F.	510	
10	CONCRETE SIDEWALK, 4" THICK	S.Y.	502	
11	BRICK PAVER SIDEWALK	S.Y.	410	
12	CONCRETE BASE COURSE, 4" THICK	S.Y.	410	
13	DETECTABLE WARNING SURFACES	S.Y.	2	
14	SODDING	S.Y.	825	
15	CRUSHED CLAM SHELLS, 4" THICK	S.Y.	440	
16	ACCESSIBILITY PARKING SIGNS AND POSTS	UNIT	4	
17	TRAFFIC MARKINGS LINES, 4"	L.F.	684	
18	TRAFFIC MARKINGS SYMBOLS	S.F.	32	
19	BICYCLE FIX-IT STATION, FURNISH AND INSTALL	UNIT	1	
20	DOUBLE-SIDED PAVER RETAINING WALL, 42" HIGH	L.F.	55	
22	SHADE PERGOLA, FURNISH AND INSTALL	LUMP SUM	LUMP SUM	
23	PICNIC TABLE WITH UMBRELLA, FURNISH AND INSTALL	UNIT	2	
24	ADA PICNIC TABLE WITH UMBRELLA, FURNISH AND INSTALL	UNIT	1	
25	ADIRONDACK CHAIRS, FURNISH AND INSTALL	UNIT	11	
26	FIRE PIT BOWL, FURNISH AND INSTALL	LUMP SUM	LUMP SUM	
27	BICYCLE RACK, FURNISH AND INSTALL	UNIT	5	
28	LITTER RECEPTACLES, FURNISH AND INSTALL	UNIT	2	
34	ENTRY SIGN, FURNISH AND INSTALL	UNIT	1	
35	TRAIL KIOSK SIGN, FURNISH AND INSTALL	UNIT	1	

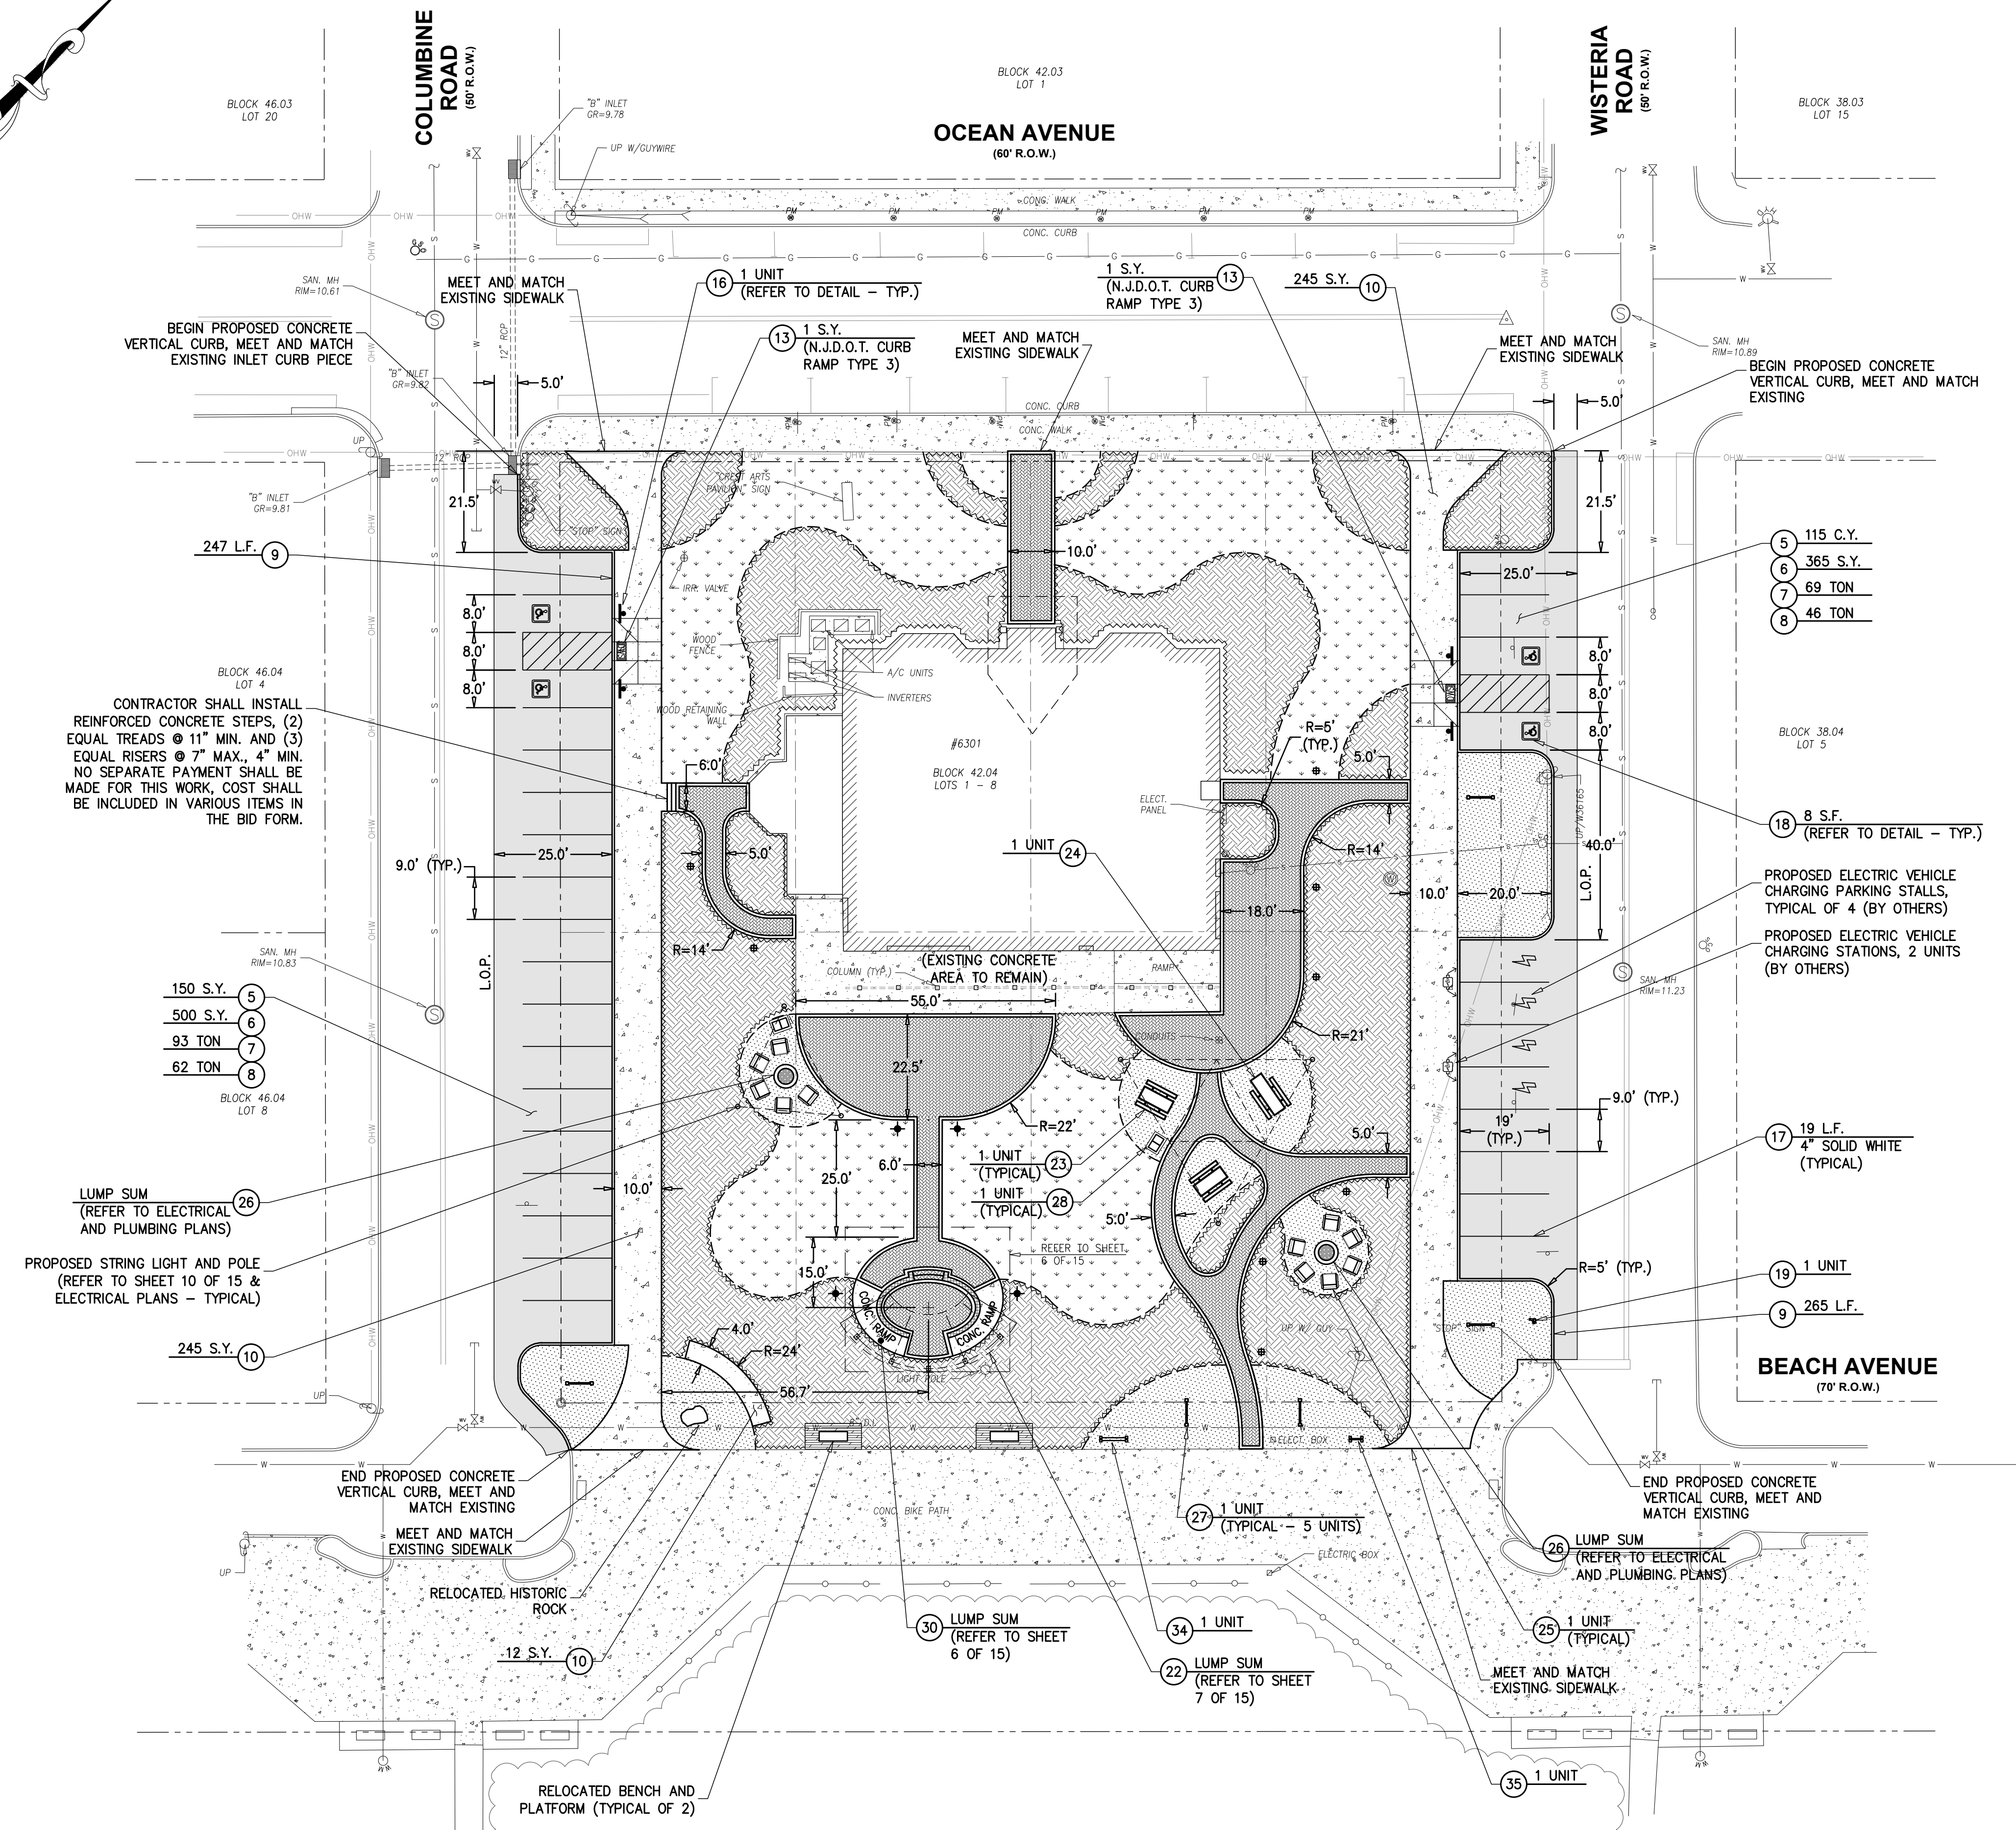

SURVEY NOTES:

- EXISTING TOPOGRAPHIC INFORMATION SHOWN WAS BASED ON A FIELD SURVEY PERFORMED BY DEBLASIO & ASSOCIATES, P.C. UNDER THE SUPERVISION OF HENRY V. ENGL, N.J.P.L.S. NO. 35833, COMPLETED ON 08/23/2023.
- ELEVATIONS SHOWN HEREON ARE IN FEET AND REFER TO THE NORTH AMERICAN VERTICAL DATUM OF 1988.
- HORIZONTAL CONTROL IS REFERENCED TO THE NEW JERSEY STATE PLANE COORDINATE SYSTEM (NAD 1983).
- PROPERTY AND RIGHT-OF-WAY LINES SHOWN ARE APPROXIMATE LOCATIONS BASED ON THE CURRENT TAX MAPS OF THE BOROUGH OF WILDWOOD CREST, CAPE MAY COUNTY, NEW JERSEY. SAID LINES ARE SHOWN FOR GRAPHICAL INFORMATION ONLY AND HAVE NOT BEEN FIELD VERIFIED.

GENERAL NOTES:


- LIMITS OF PAVING (L.O.P.) SHALL BE SAWCUT FULL DEPTH AND SEALED WITH HOT-POURED JOINT SEALER, MEET AND MATCH EXISTING PAVEMENT ELEVATIONS. THERE SHALL BE NO SEPARATE PAYMENT FOR THIS WORK BUT THE COST SHALL BE INCLUDED IN THE SURFACE PAVING.
- LIMITS OF SIDEWALK REPLACEMENT SHALL BE SAWCUT TO A NEAT AND CLEAN EDGE WHERE NO JOINT EXISTS. THE COSTS OF SAWCUTTING SHALL BE INCLUDED IN THE RELATED PAY ITEMS IN THE BID FORM.

STRIPING NOTES:

- ALL PERMANENT LONGITUDINAL WHITE AND YELLOW LANE LINES SHALL BE LONG-LIFE EPOXY RESIN TRAFFIC STRIPES.
- ALL PERMANENT DIAGONAL GORE MARKINGS, CROSS WALKS, STOP BARS, PARKING STALL DELINEATORS, WORDS, AND ARROWS SHALL BE LONG-LIFE THERMOPLASTIC TRAFFIC MARKINGS.
- TRAFFIC STRIPING AND TRAFFIC MARKINGS OF DIFFERENT MATERIALS SHALL NOT BE OVERLAPPED.

LEGEND

- PROPOSED CONCRETE SIDEWALK (ITEM NO. 10)
- PROPOSED BRICK PAVERS AND CONCRETE BASE COURSE (ITEMS NO. 11 & NO. 12)
- PROPOSED PLANTING AREA (ITEM NO. 32 - REFER TO PLANTING PLANS)
- PROPOSED SOD (ITEM NO. 14)
- PROPOSED CRUSHED CLAM SHELLS (ITEM NO. 15)
- PROPOSED ASPHALT
- PROPOSED LIGHT COLUMN (REFER SHEET 10 OF 15 & ELECTRICAL PLANS)
- PROPOSED ILLUMINATED BOLLARD (REFER SHEET 10 OF 15 & ELECTRICAL PLANS)

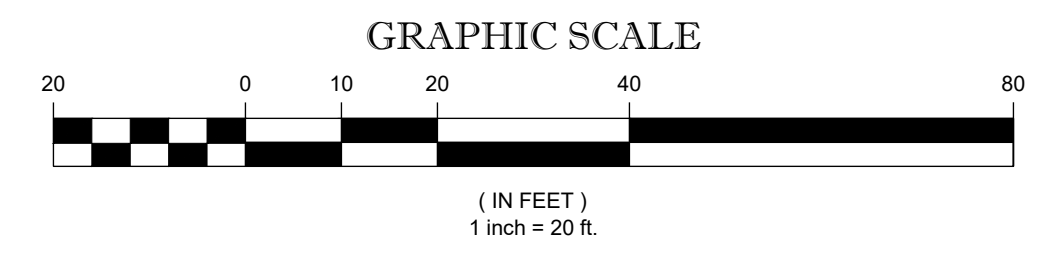

PROPOSED SITE PLAN

DeBlasio & Associates
CONSULTING ENGINEERS AND PLANNERS

4701 NEW JERSEY AVENUE
WILDWOOD, NJ 08260
PHONE (609) 854-3311
FAX (609) 854-4323
WWW.DEBLASIOASSOC.COM
Certification of Authorization No. 246A28284900

CAPE MAY COUNTY OPEN SPACE PROGRAM
CREST ARTS PAVILION
SITE IMPROVEMENTS
BOROUGH OF WILDWOOD CREST
CAPE MAY COUNTY, NEW JERSEY

Design:	Drawn:	Check:	Date:
MWA	MWA	MAD	12/05/2023

Man DeBlasio 12/5/2023
MARC A. DEBLASIO, PE DATE
New Jersey License No. 41599

NO.	DATE	APPR.	REVISION

COPYRIGHT 2023, DEBLASIO & ASSOCIATES, P.C. - ALL RIGHTS RESERVED. THE COPYING OR REUSE OF THIS DOCUMENT OR PORTIONS THEREOF, FOR OTHER THAN THE ORIGINAL PROJECT OR THE PURPOSE ORIGINALLY INTENDED, WITHOUT THE WRITTEN PERMISSION OF DEBLASIO & ASSOCIATES, P.C. IS PROHIBITED.